
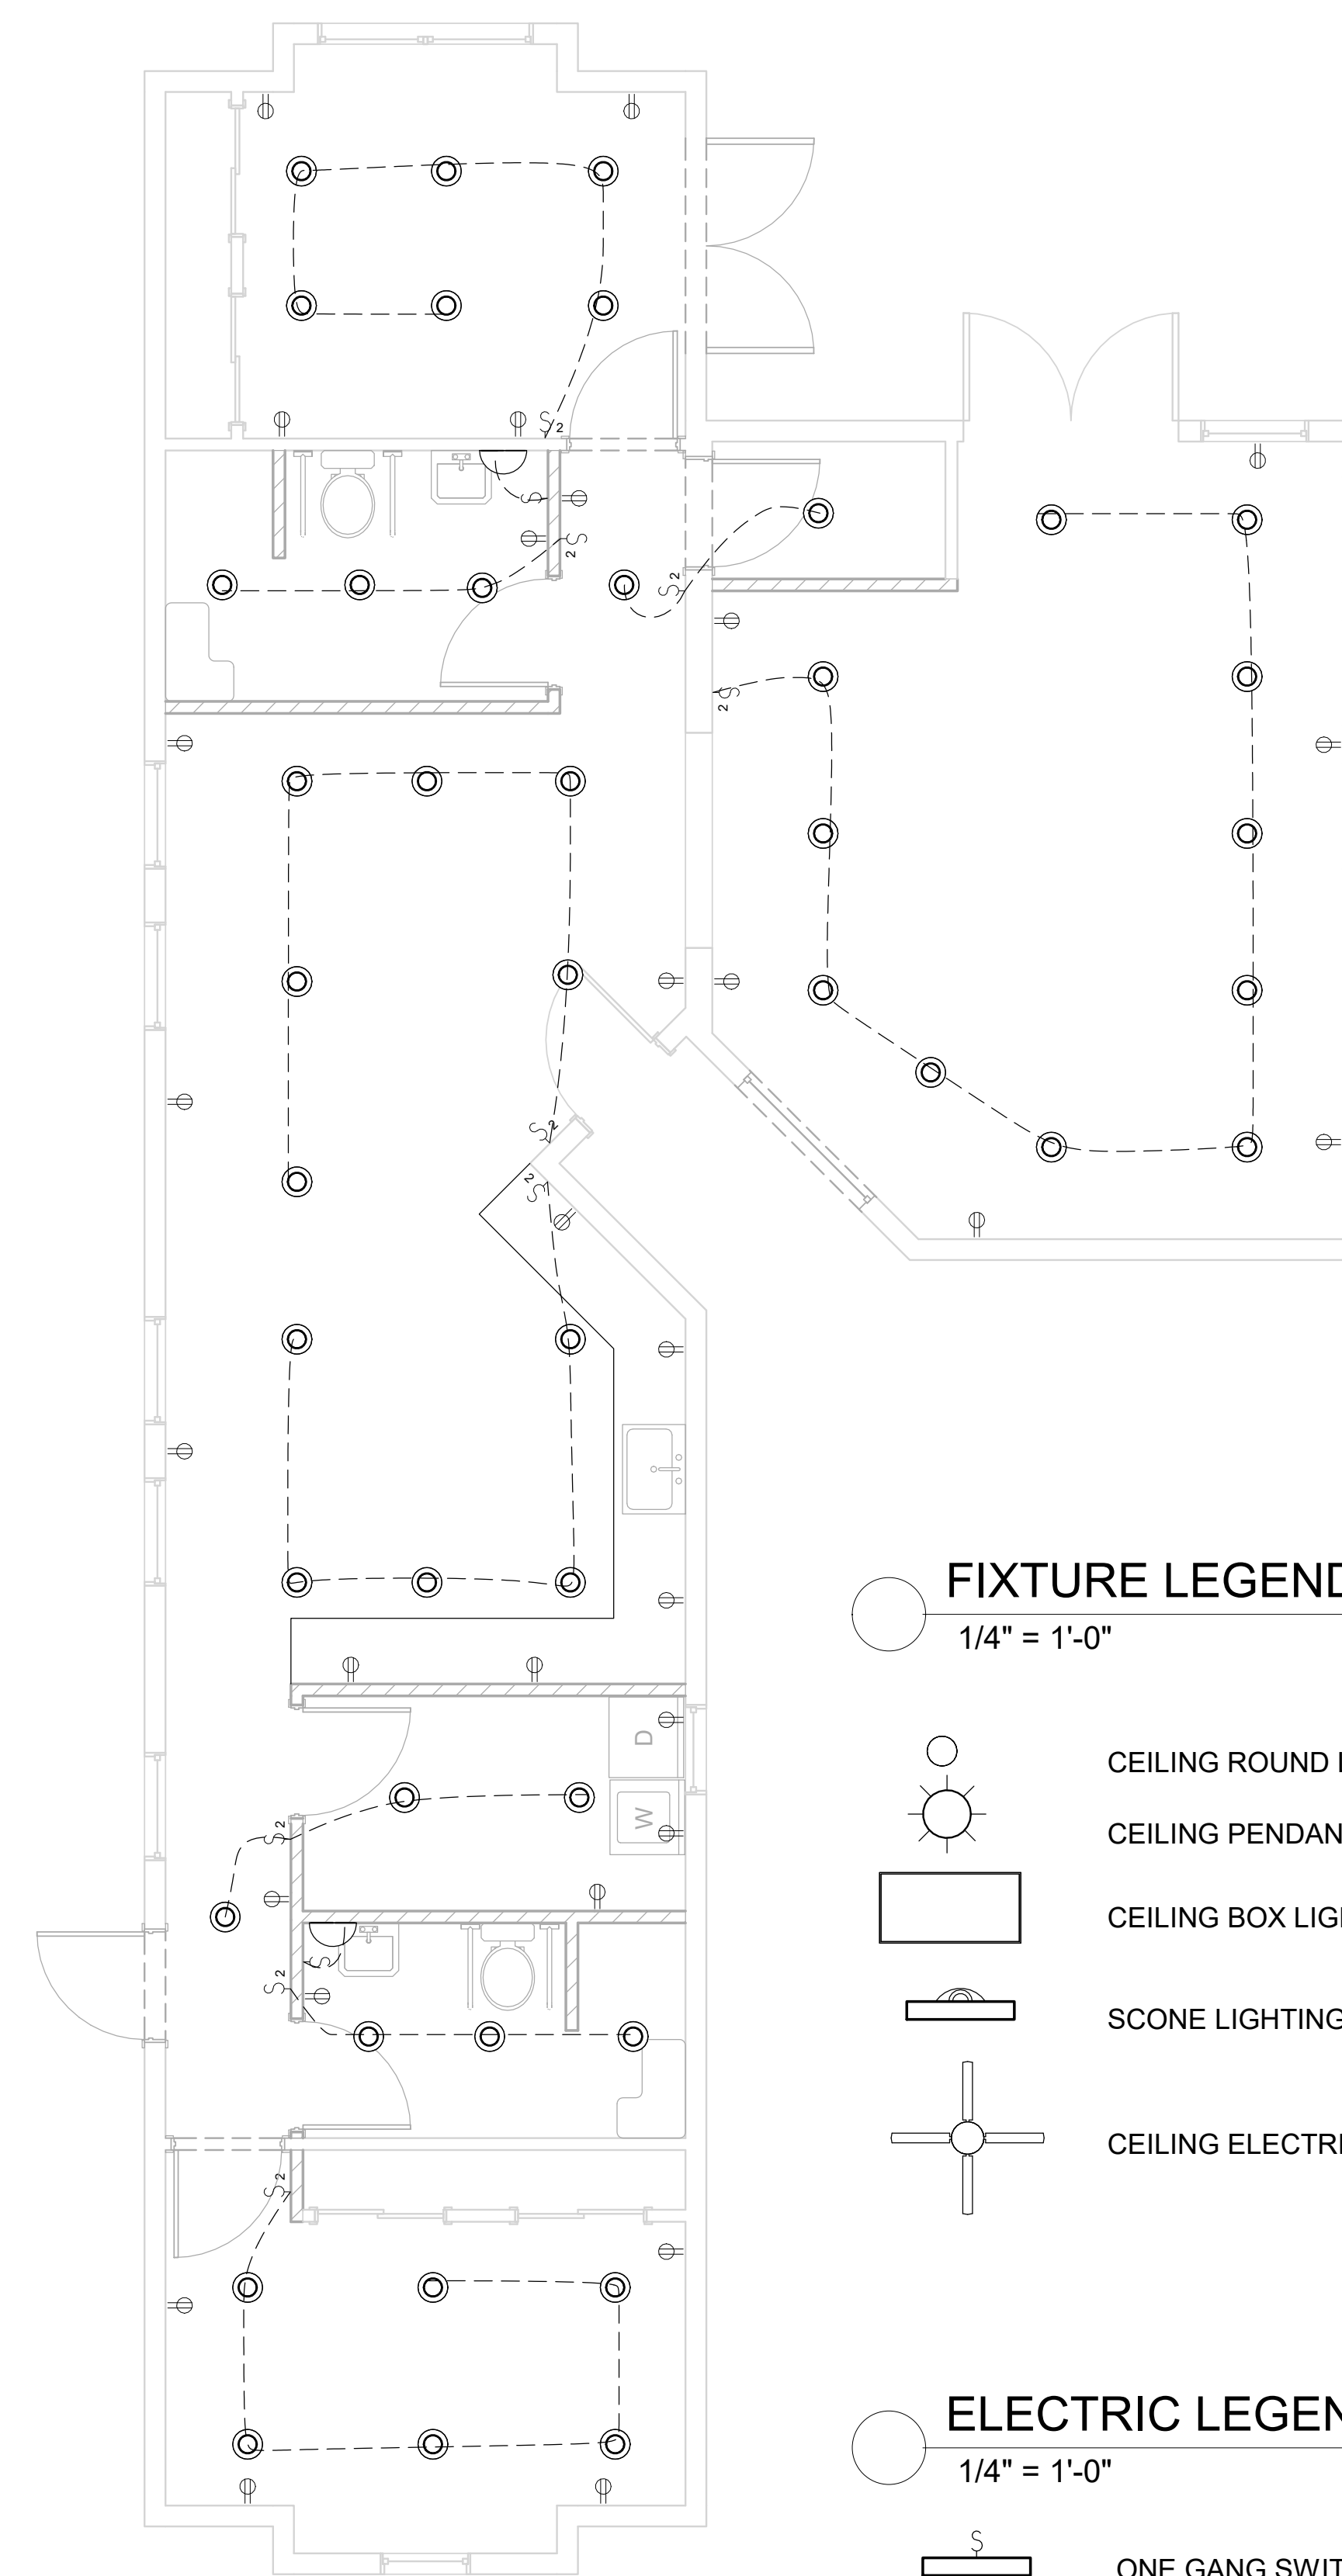


[illegible]

ONE STORY HOUSE	
REMODEL PROJECT	
PLUMBING & ELECTRICAL PLAN	
Project number	12020
Date	JAN. 16-2020
Drawn by	Author
Checked by	Checker
A102	
Scale	1/4" = 1'-0"

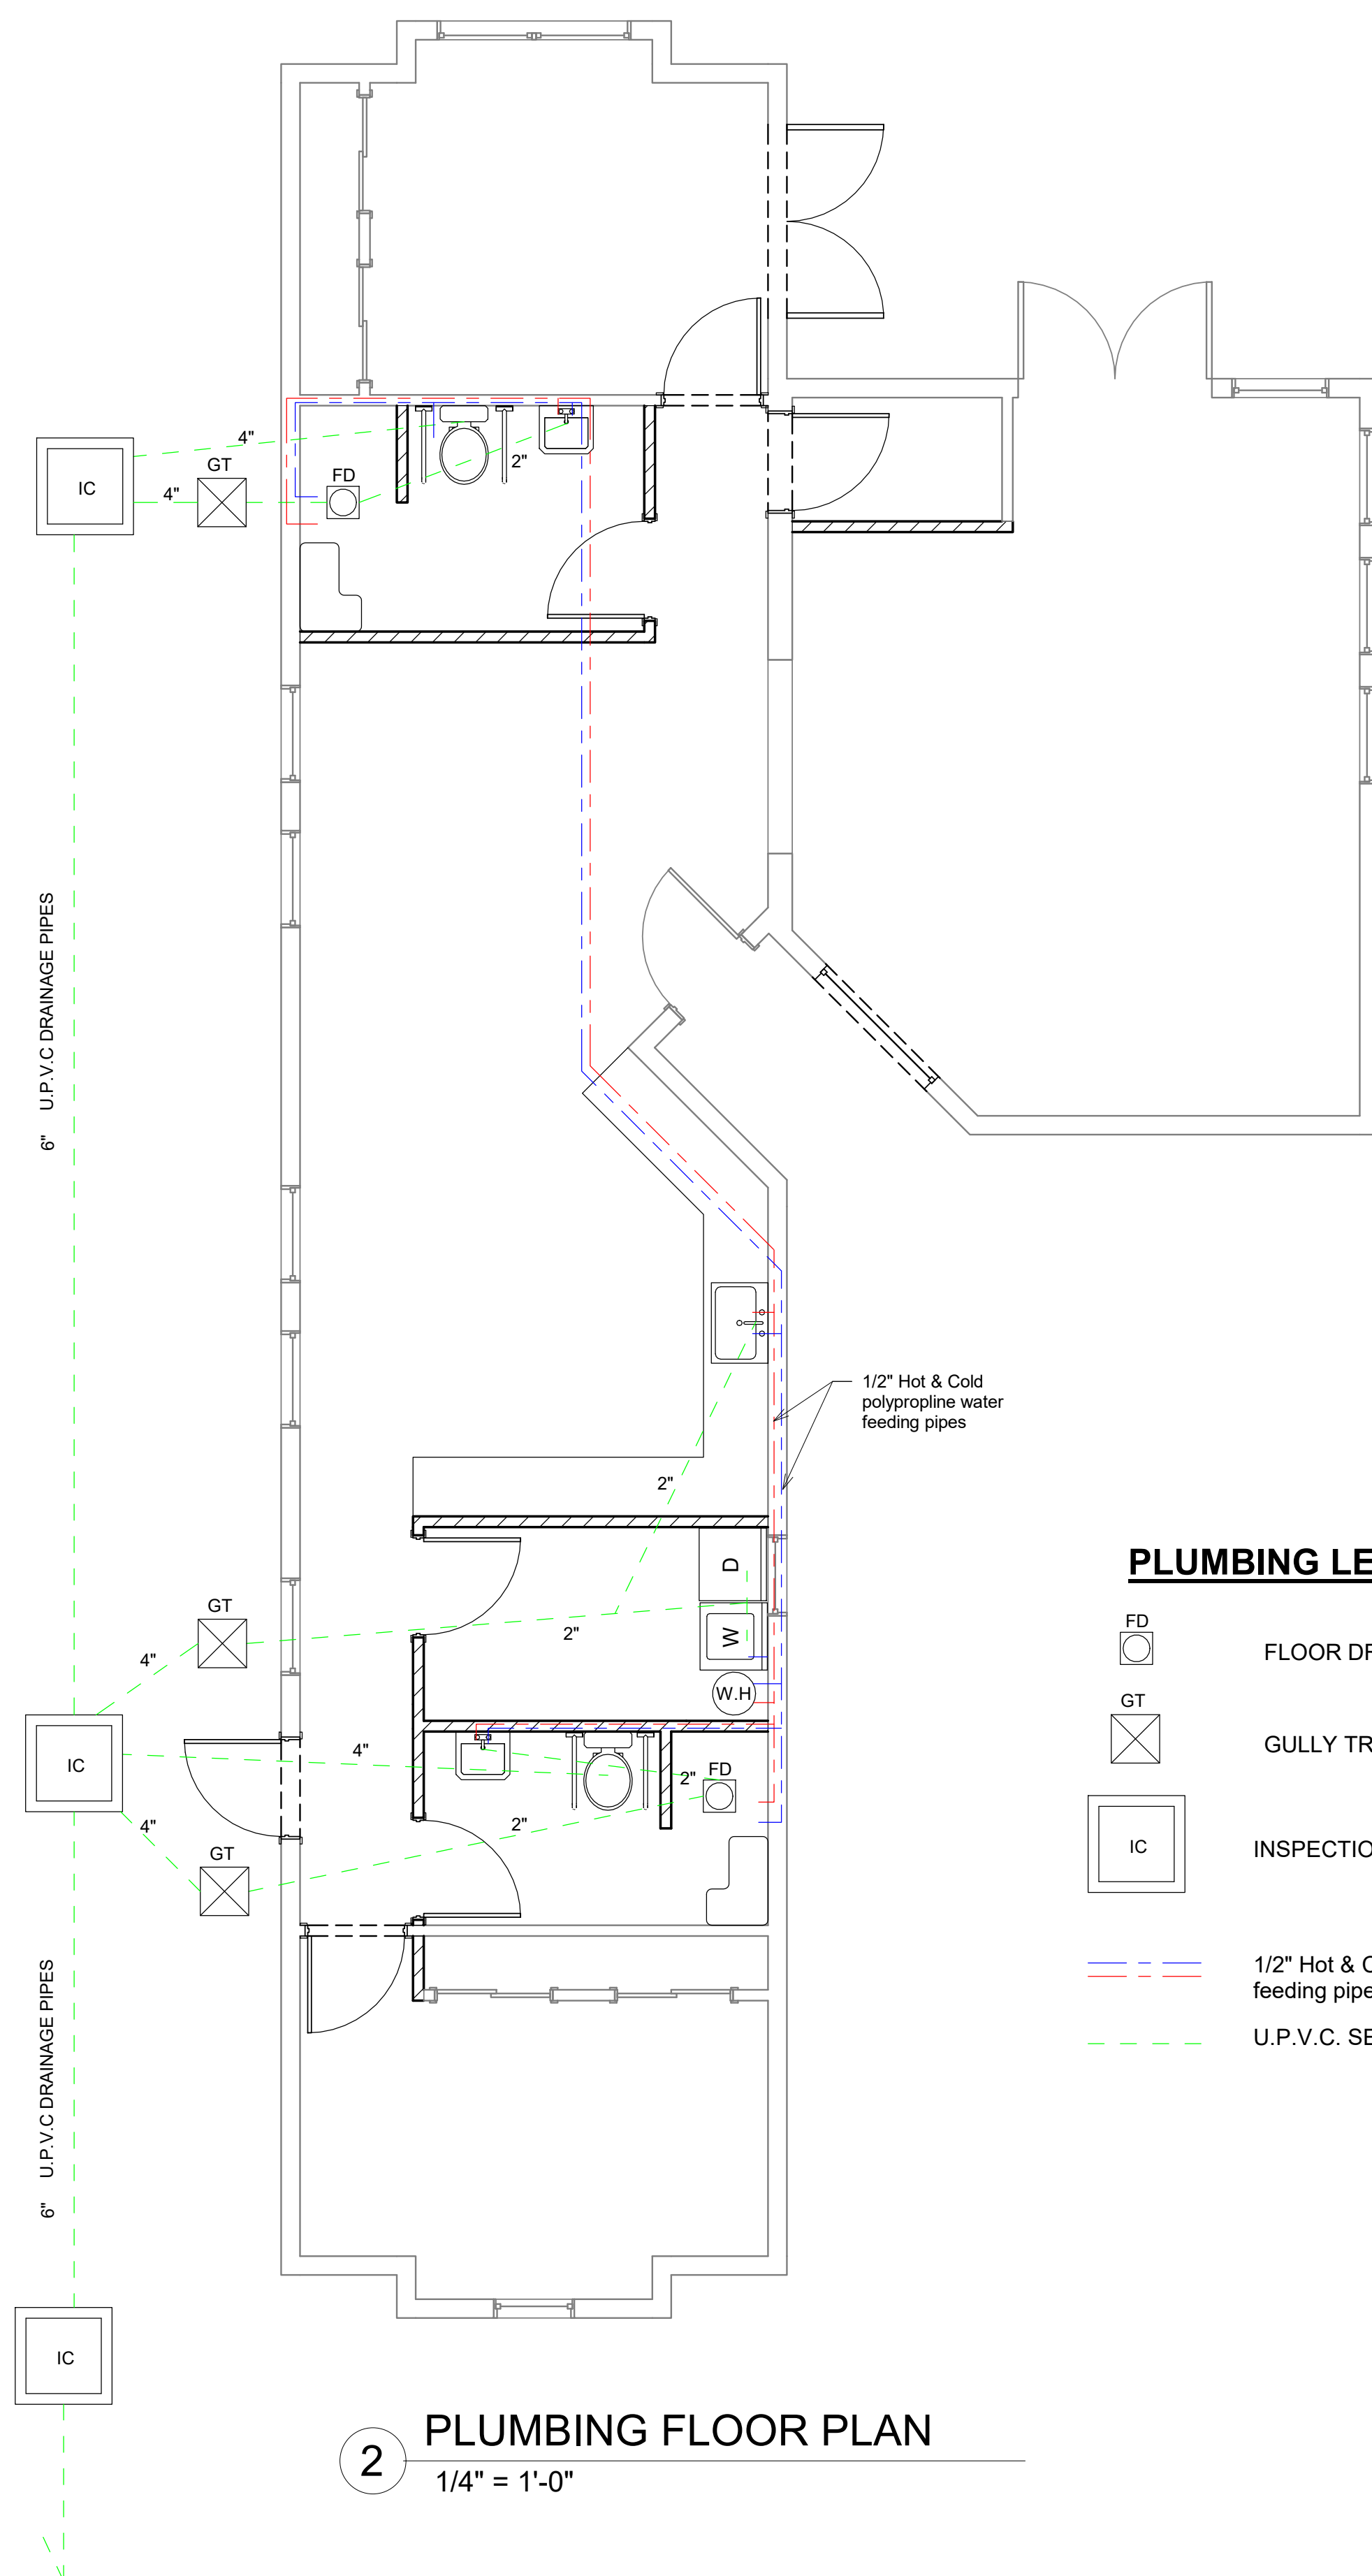

***** LEGEND**

- 2 PROPOSED FLOOR PLAN
1/4" = 1'-0"

[illegible]

ONE STORY HOUSE
REMODEL PROJECT

FLOOR PLAN

Project number	12020
Date	JAN. 16-2020
Drawn by	MS
Checked by	MS

A101

Scale	As indicated
-------	--------------

[illegible]

HVAC PLAN

A103	
Scale	$1/4" = 1'-0"$